



REVISIONS			
SYM	DESCRIPTION	DATE	APPROVED
(C)	REVISED GRADING & LIMIT OF WORK	3/11/77	LL

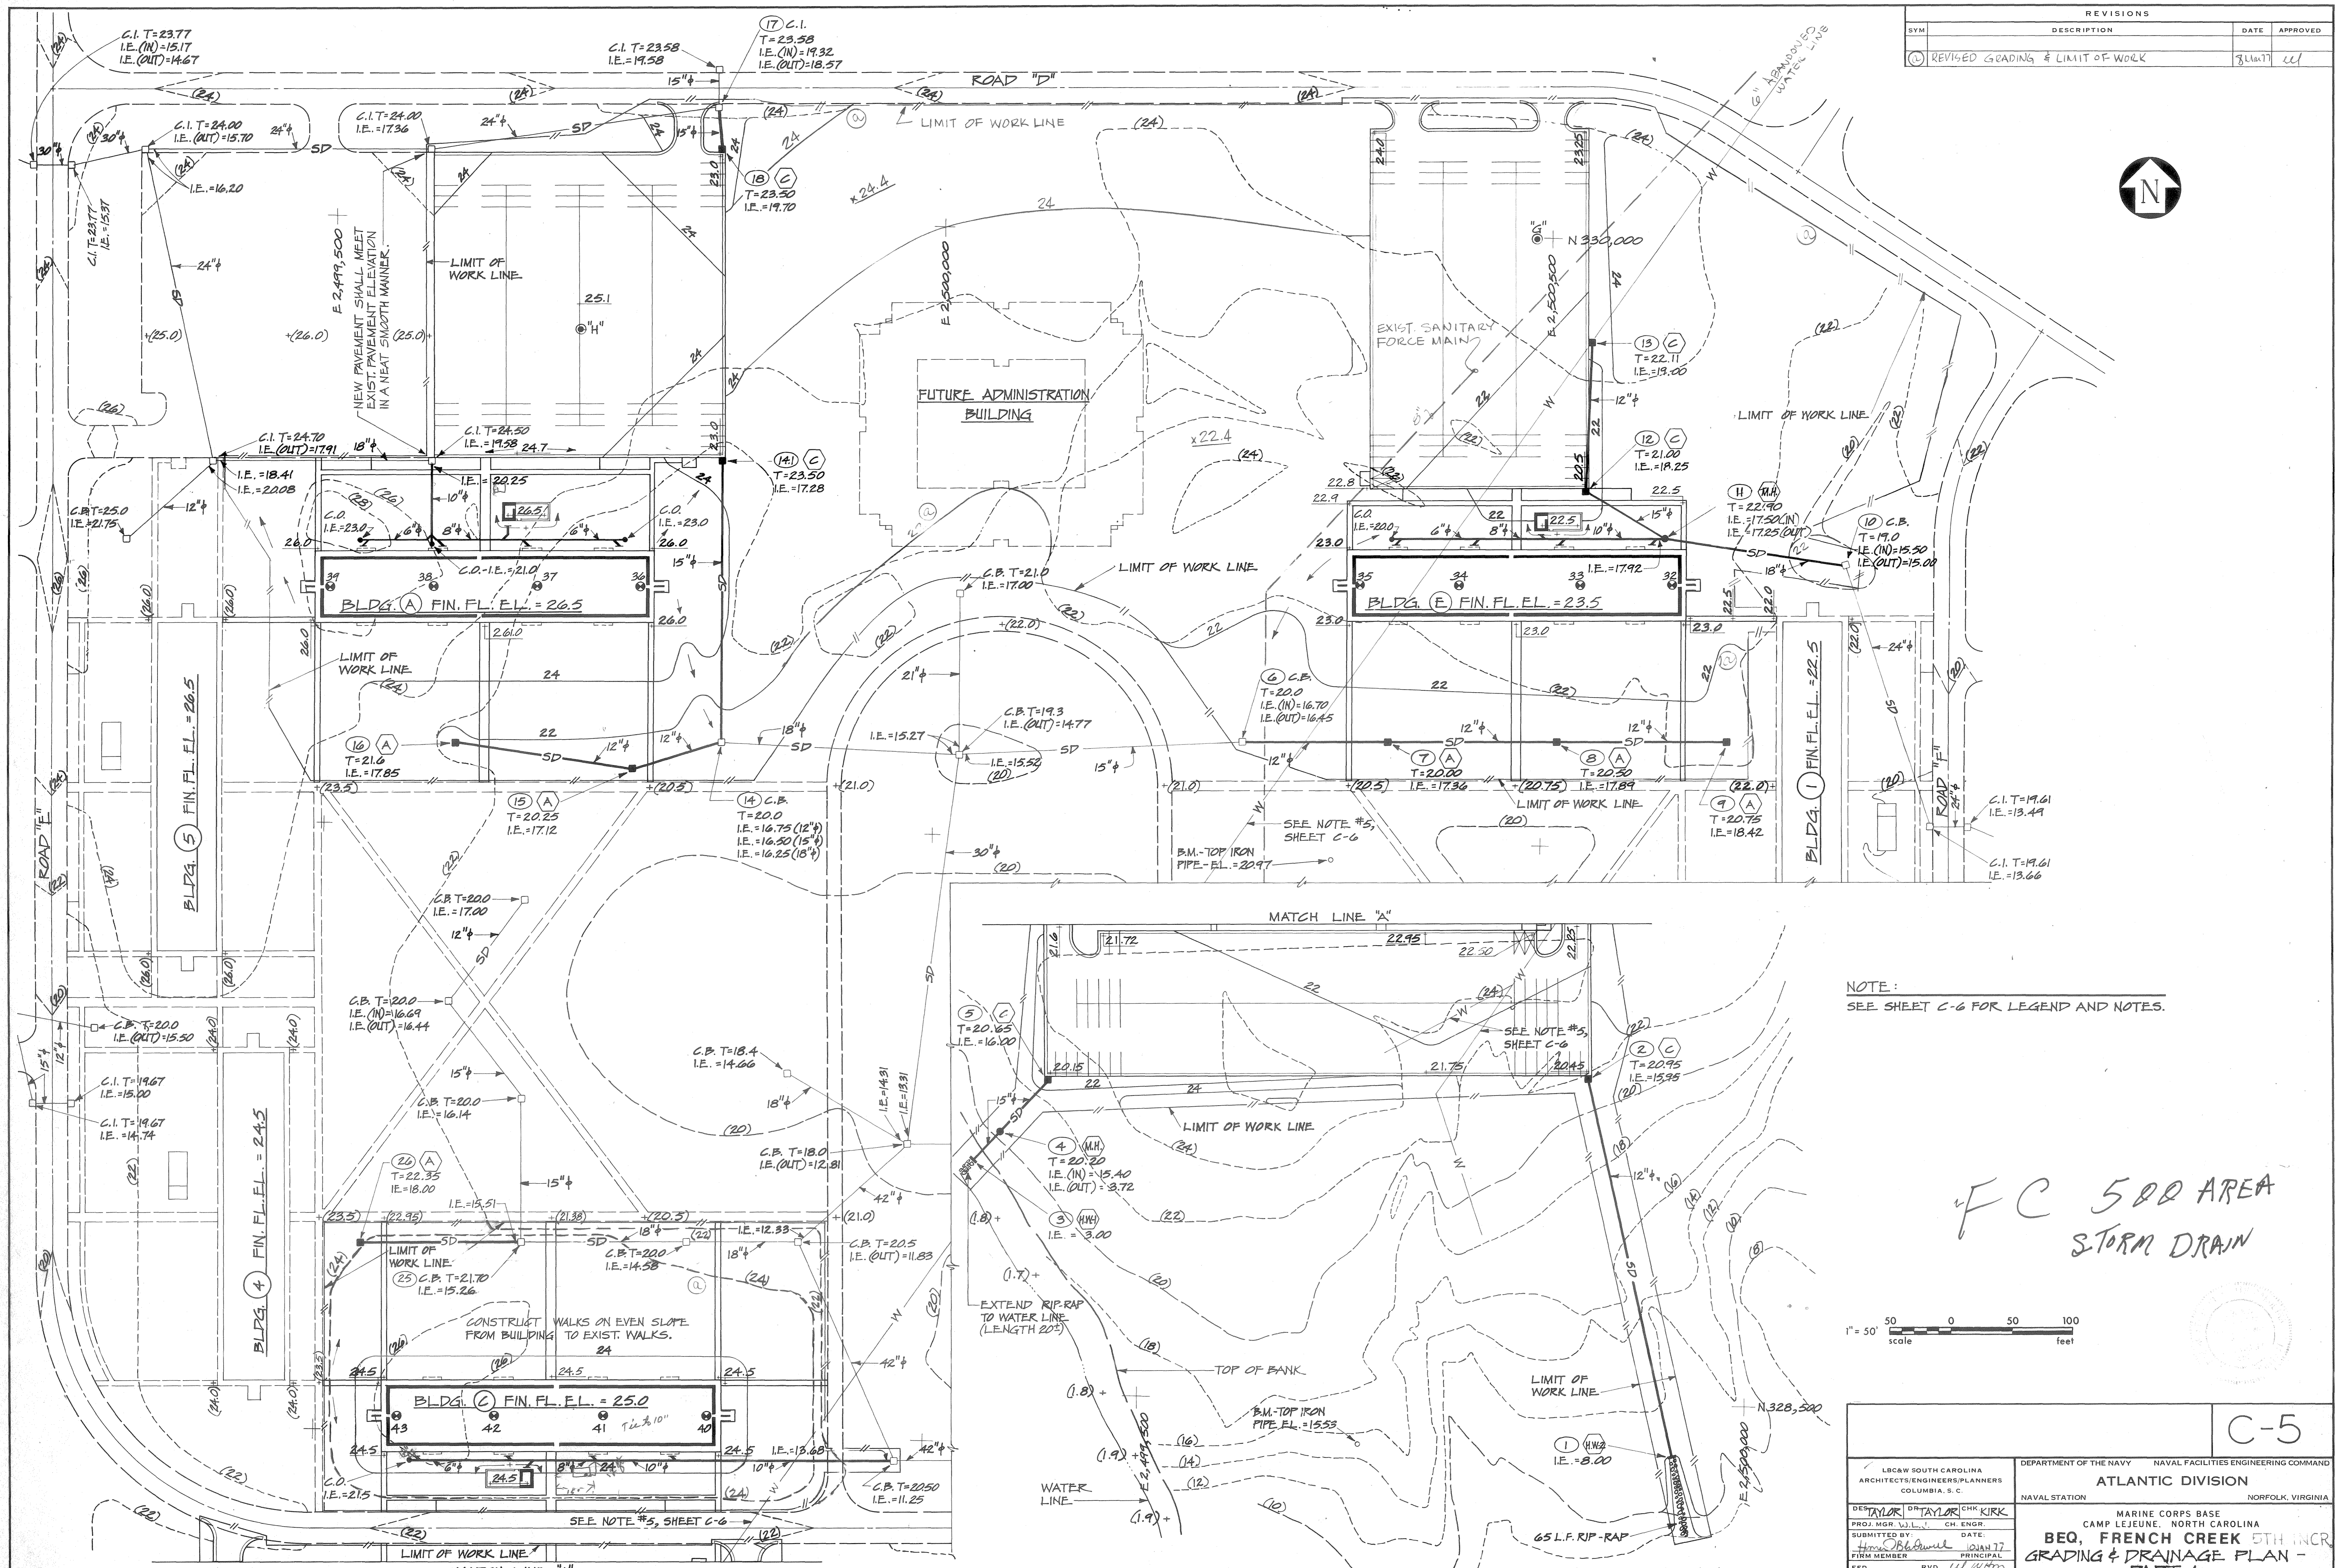

NOTE:
SEE SHEET C-6 FOR LEGEND AND NOTES.

FC 500 AREA
STORM DRAIN

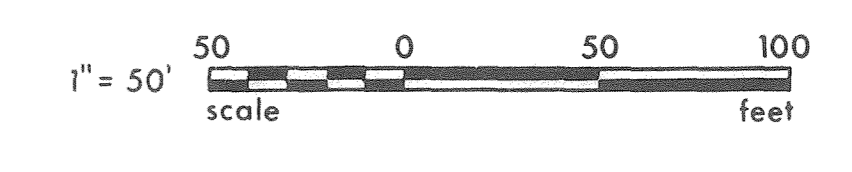

SATISFACTORY TO
[Signature]
DATE 1/12/77

C-5	
LEICAW SOUTH CAROLINA ARCHITECTS/ENGINEERS/PLANNERS COLUMBIA, S. C.	DEPARTMENT OF THE NAVY NAVAL FACILITIES ENGINEERING COMMAND ATLANTIC DIVISION NORFOLK, VIRGINIA
DESIGNED BY: TAYLOR PROJECT MGR.: J.L.L.C. SUBMITTED BY: [Signature] FIRM MEMBER: [Signature] E.P.D. NO.: [Signature] APPROVED: [Signature]	NAVAL STATION: MARINE CORPS BASE CAMP LEJEUNE, NORTH CAROLINA REQ. FRENCH CREEK 5TH INCR GRADING & DRAINAGE PLAN - PART 1
DATE: 10/28/77	NAVAFAC DRAWING NO.: 4031964
OFFICER IN CHARGE: [Signature]	SIZE: F 80091
DATE: [Signature]	CONSTR. CONTR. NO. N62470-75-B-5320
FOR EFD FOR COMMANDER NAVFAC	SHEET 26 OF 77 EFD DWG. NO. 131964

