




REVISIONS			
SYM	DESCRIPTION	DATE	APPROVED

PROJECT SUMMARY - JUNIOR ENLISTED MEN

NO.	TITLE	SCALE	DATE
1			
2			
3			
100			

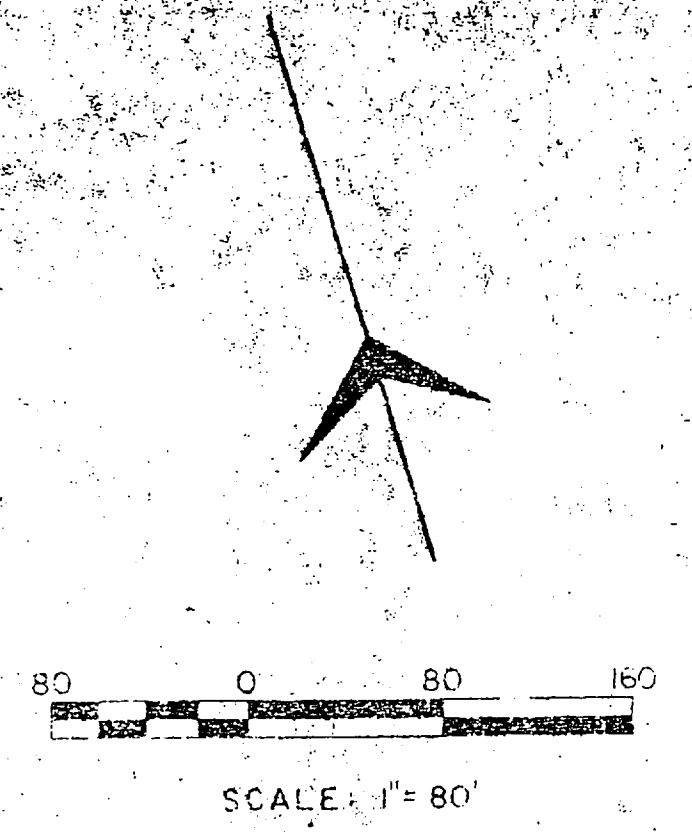

- BUILDING TYPE A = JEM 4 DUPLEX
- BUILDING TYPE B = JEM 4 FOURPLEX
- BUILDING TYPE C = JEM 3 DUPLEX
- BUILDING TYPE D = JEM 3 FOURPLEX

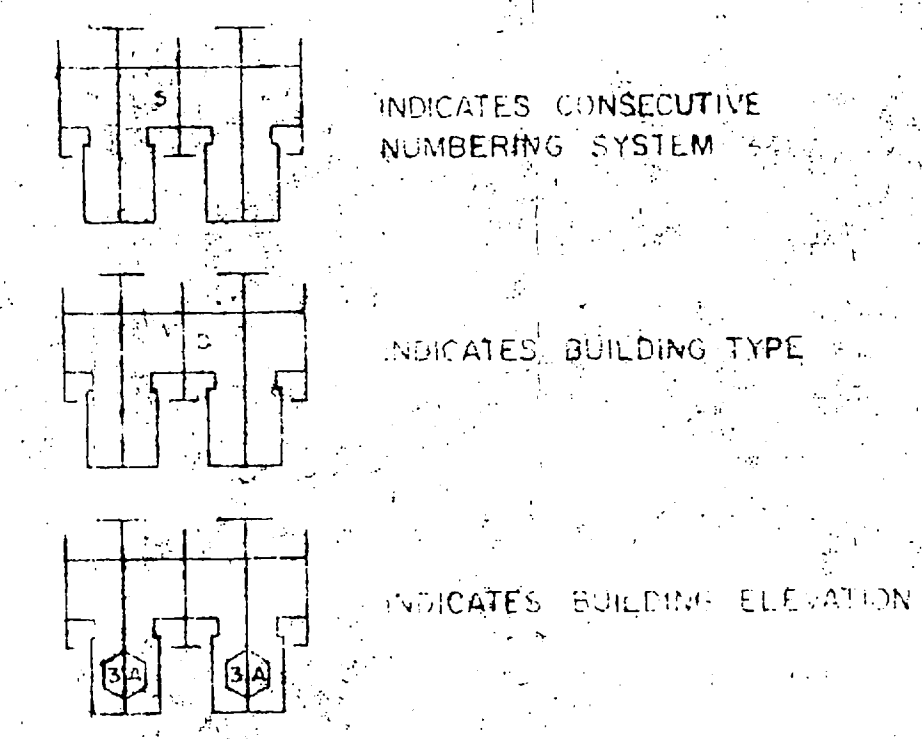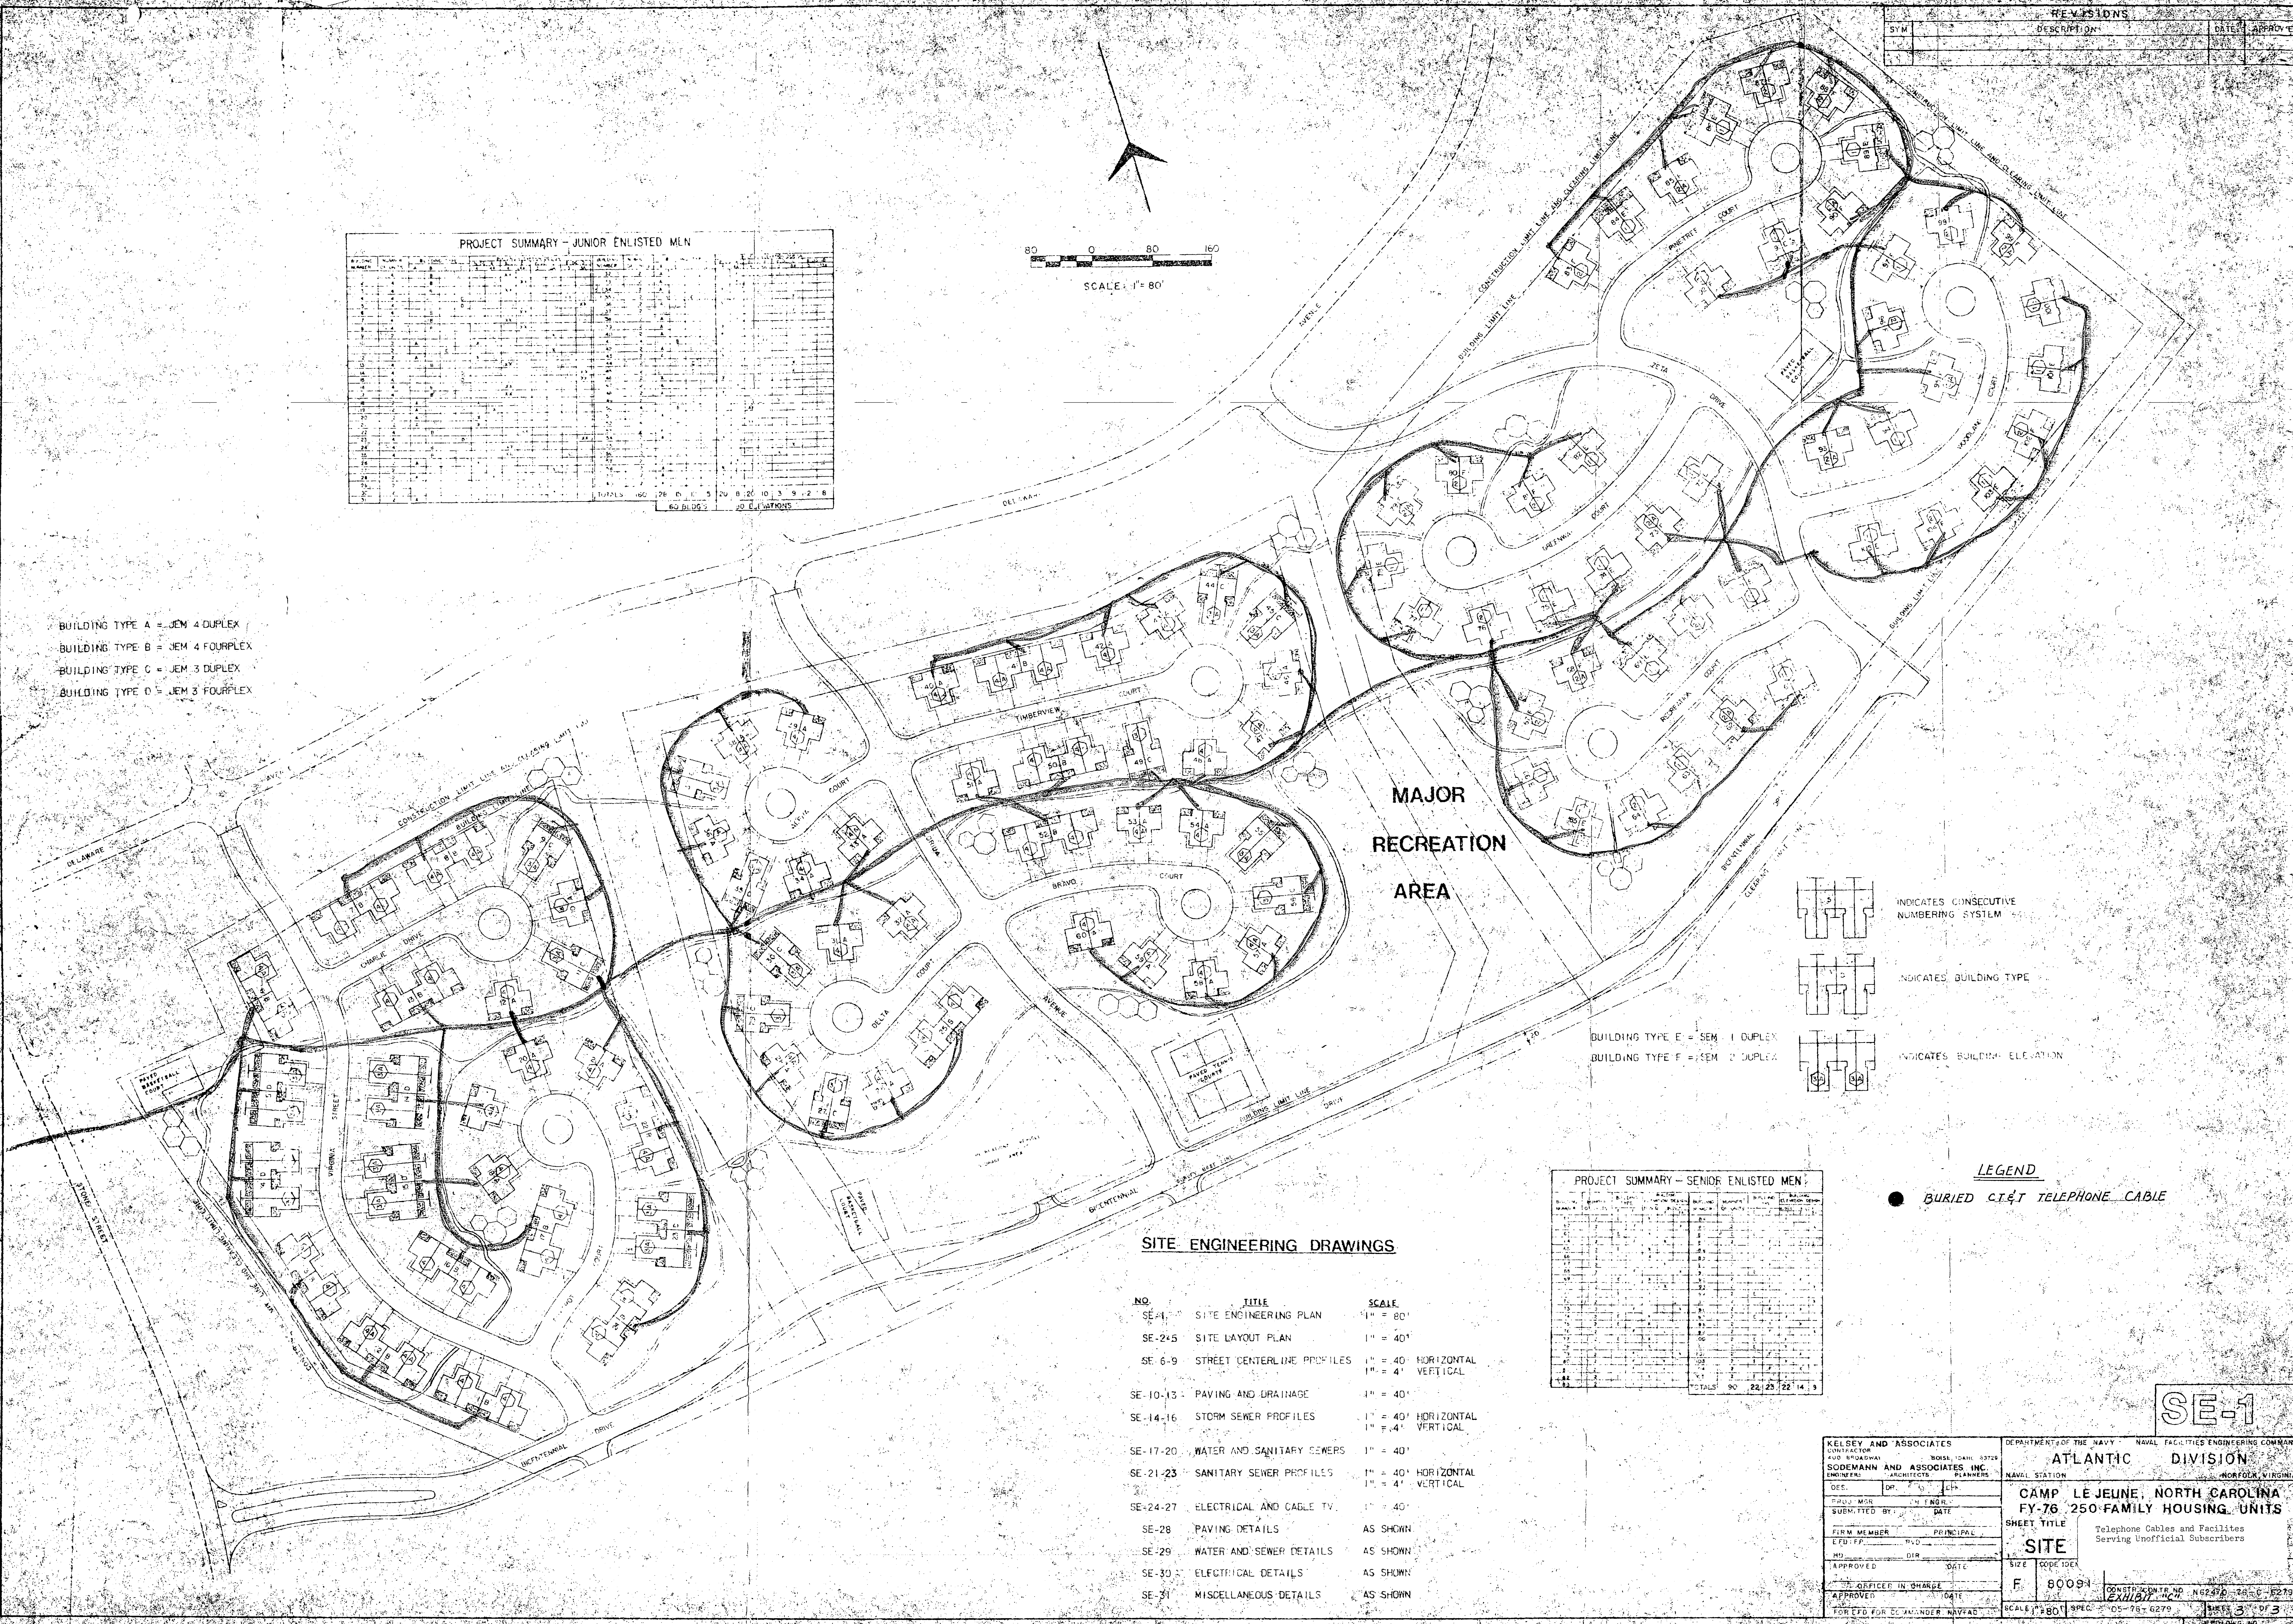

PROJECT SUMMARY - SENIOR ENLISTED MEN

NO.	TITLE	SCALE	DATE
1			
2			
3			
100			

SITE ENGINEERING DRAWINGS

NO.	TITLE	SCALE
SE-1	SITE ENGINEERING PLAN	1" = 80'
SE-2-5	SITE LAYOUT PLAN	1" = 40'
SE-6-9	STREET CENTERLINE PROFILES	1" = 40' HORIZONTAL 1" = 4' VERTICAL
SE-10-13	PAVING AND DRAINAGE	1" = 40'
SE-14-16	STORM SEWER PROFILES	1" = 40' HORIZONTAL 1" = 4' VERTICAL
SE-17-20	WATER AND SANITARY SEWERS	1" = 40'
SE-21-23	SANITARY SEWER PROFILES	1" = 40' HORIZONTAL 1" = 4' VERTICAL
SE-24-27	ELECTRICAL AND CABLE TV	1" = 40'
SE-28	PAVING DETAILS	AS SHOWN
SE-29	WATER AND SEWER DETAILS	AS SHOWN
SE-30	ELECTRICAL DETAILS	AS SHOWN
SE-31	MISCELLANEOUS DETAILS	AS SHOWN

LEGEND
● BURIED C&T TELEPHONE CABLE

SE-1

KELSEY AND ASSOCIATES CONTRACTOR 4401 KINGSWAY NORFOLK, VA 23510	DEPARTMENTS OF THE NAVY - NAVAL FACILITIES ENGINEERING COMMAND ATLANTIC DIVISION NAVAL STATION MORFOLK, VIRGINIA
SODEMANN AND ASSOCIATES INC. ARCHITECTS PLANNERS 1000 W. 17TH ST. NORFOLK, VA 23510	CAMP LE JEUNE, NORTH CAROLINA FY-76 250 FAMILY HOUSING UNITS
DESIGNED BY: [] DATE: [] CHECKED BY: [] DATE: [] SUBMITTED BY: [] DATE: []	SHEET TITLE SITE Telephone Cables and Facilities Serving Unofficial Subscribers
FIRM MEMBER: [] PRINCIPAL: [] NO. [] APPROVED: [] DATE: []	SIZE: [] CODE INDEX: []
OFFICER IN CHARGE: [] APPROVED: [] DATE: []	F 80091 CONSTRUCTION NO. N62370-66-C-10279
FOR EXP. BY: [] NAVFAC: []	SCALE: 1"=80' SPEC: 98-6279 SHEETS: 3 OF 3

SKETCH No. 341

