

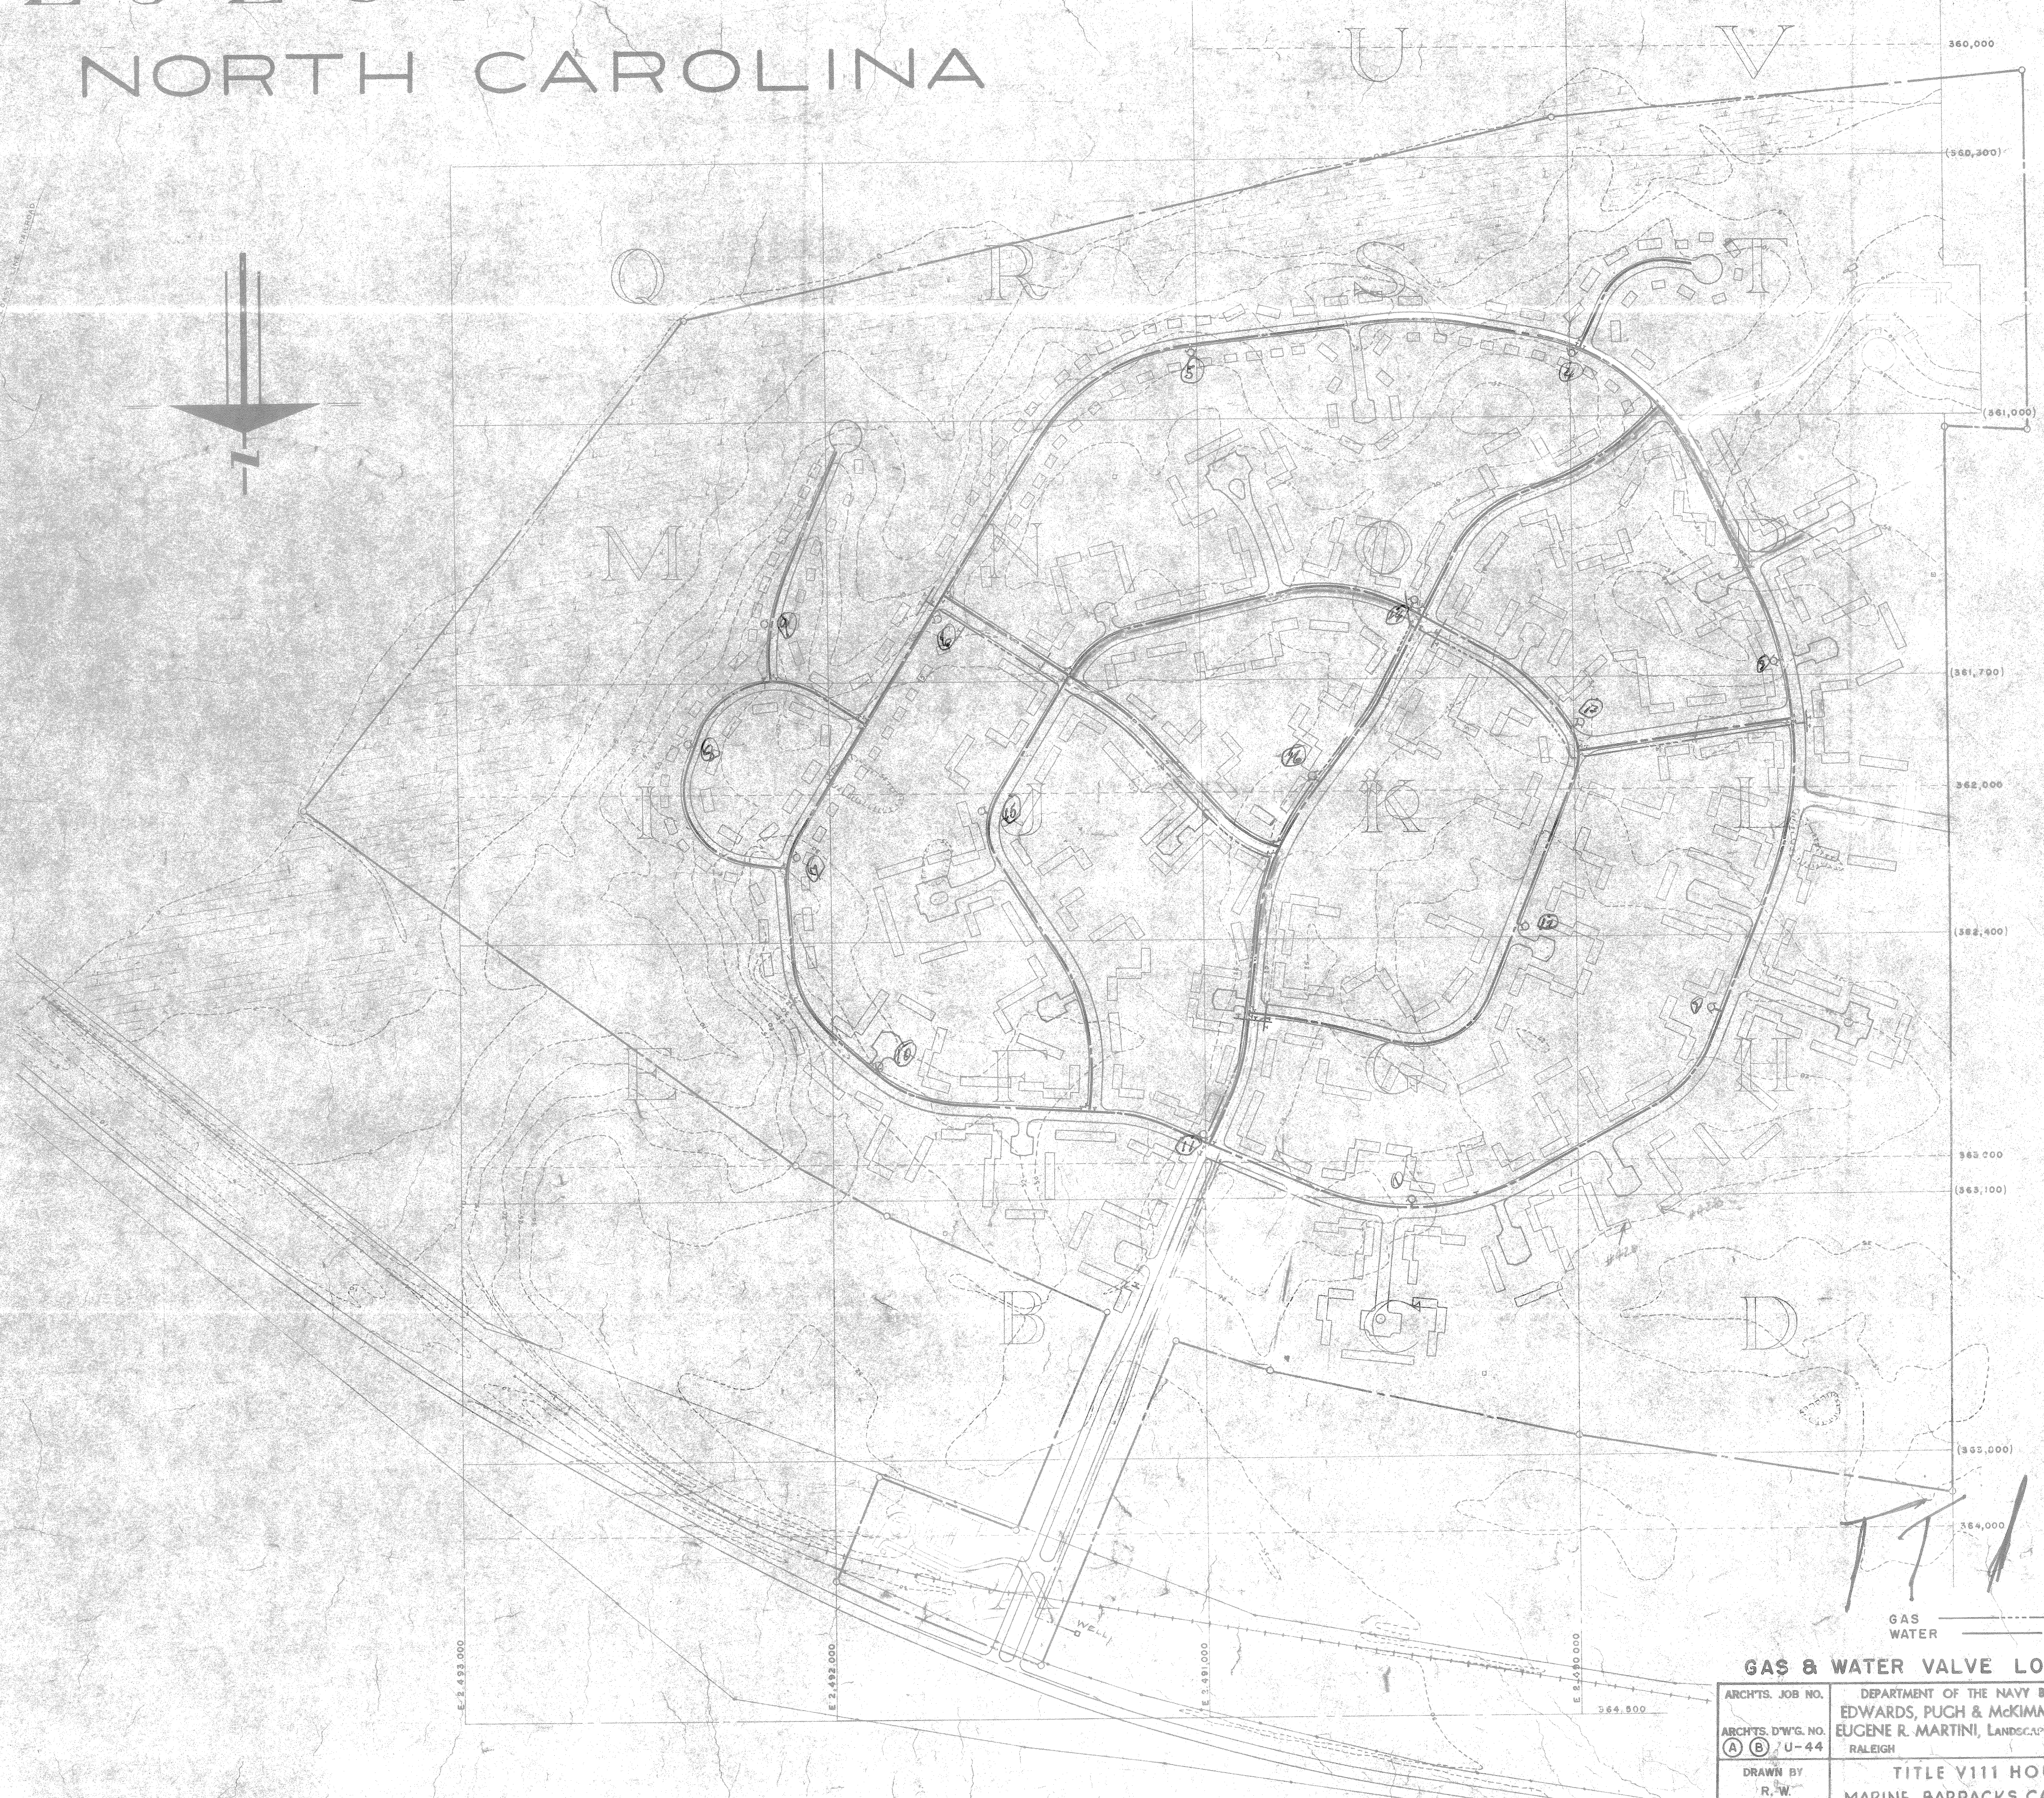


CAMP LEJEUNE HOUSING PROJECT

NEW RIVER, NORTH CAROLINA

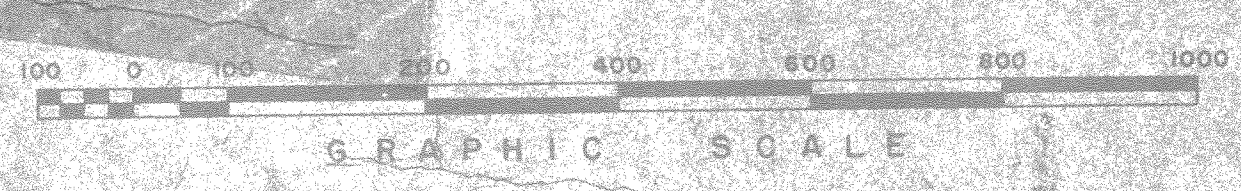

LOCATION MAP
NOT TO SCALE

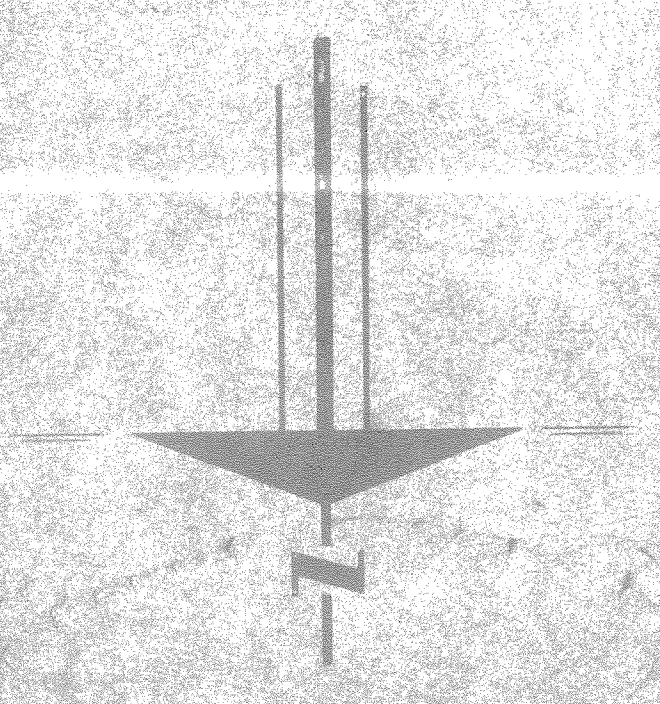

T.T.T.
GAS
WATER

GAS & WATER VALVE LOCATION PLAN

ARCHTS. JOB NO.	DEPARTMENT OF THE NAVY BUREAU OF YARDS AND DOCKS		
ARCHTS. D'WG. NO.	EDWARDS, PUGH & McKIMMON - LEIF VALAND, ARCHTS.		
(A) (B) U-44	EUGENE R. MARTINI, LANDSCAPE ARCHITECT & PLANNING CONSULTANT		
	RALEIGH NORTH CAROLINA		
DRAWN BY	TITLE VIII HOUSING PROJECT		
R. W.	MARINE BARRACKS CAMP LEJEUNE, N. C.		
CHECKED BY	TARAWA TERRACE		
J. D. L.			
DATE	APPROVED	DATE	
1-2-51	<i>[Signature]</i>		
APPROVED FOR	DISTRICT PUBLIC WORKS OFFICER		
DATE	SCALE	SPEC.	
	SHEET	OF NOV	
	Y & D DRAWING NO.		



1-19-51	ADDED 7 PARKING SPACES	DATE	BY

CAMP LEJEUNE HOUSING PROJECT II

NEW RIVER, NORTH CAROLINA

TARAWA TERRACE II

OVERALL UTILITY PLAN

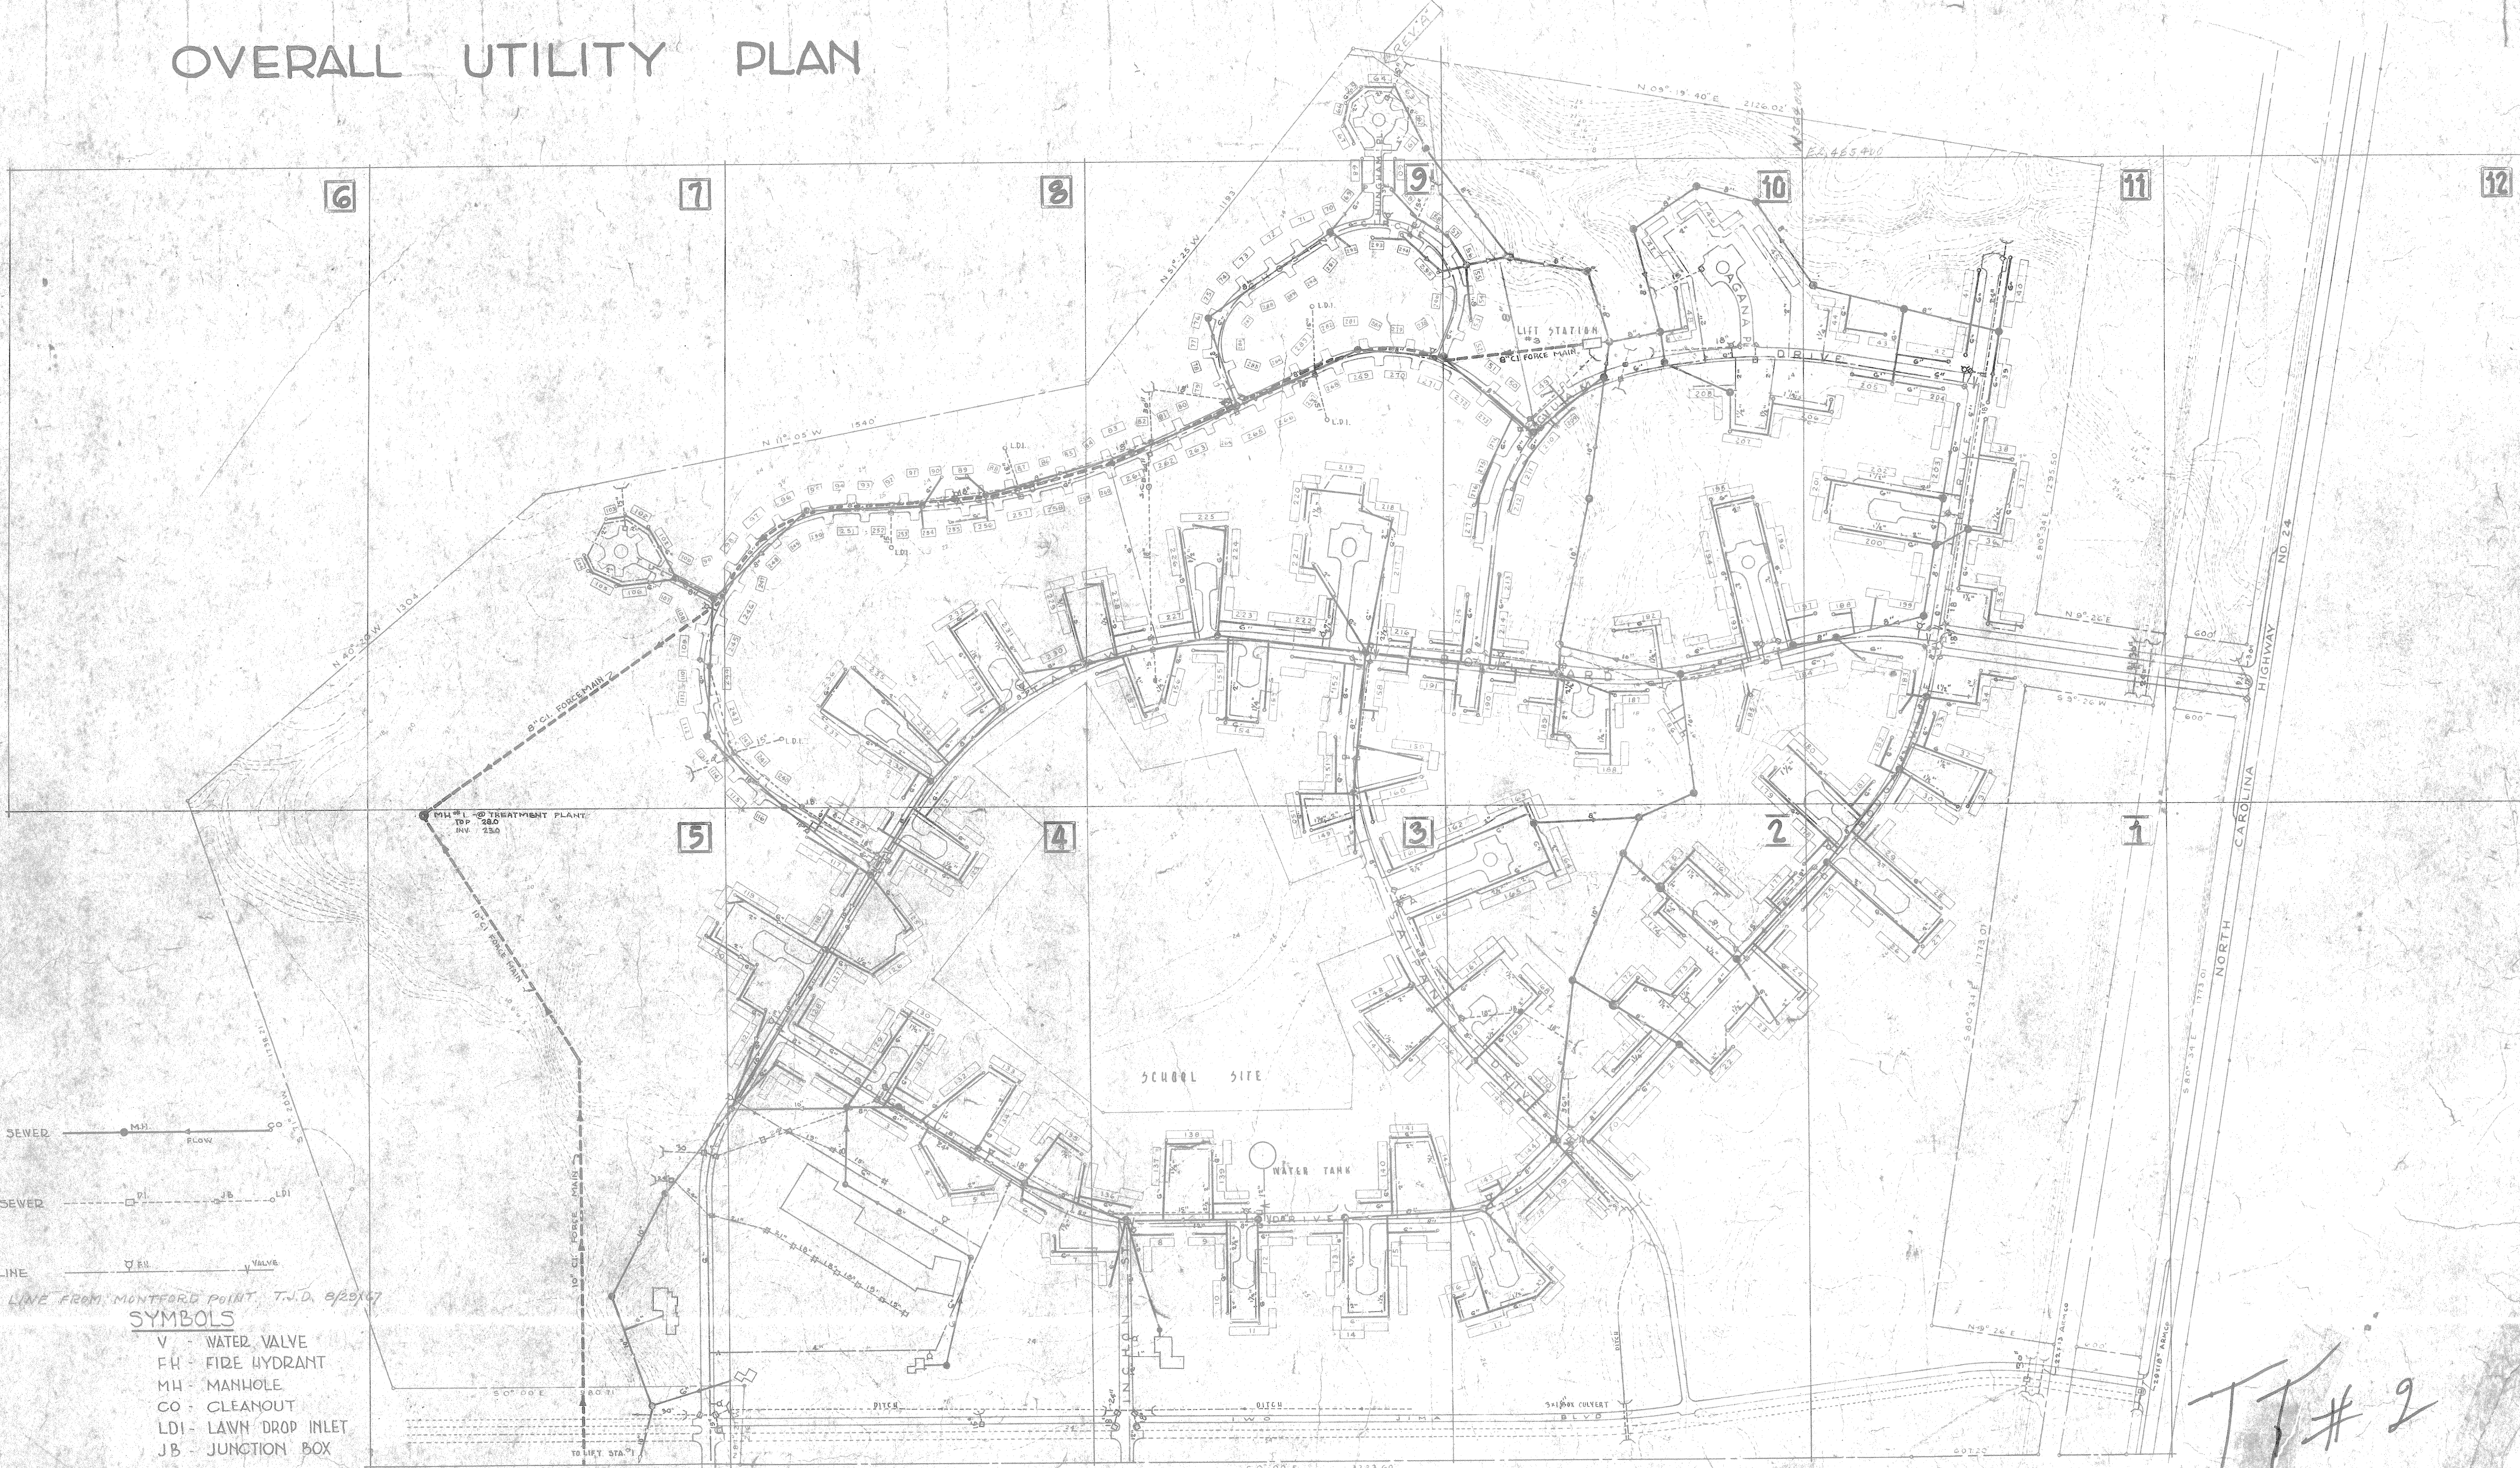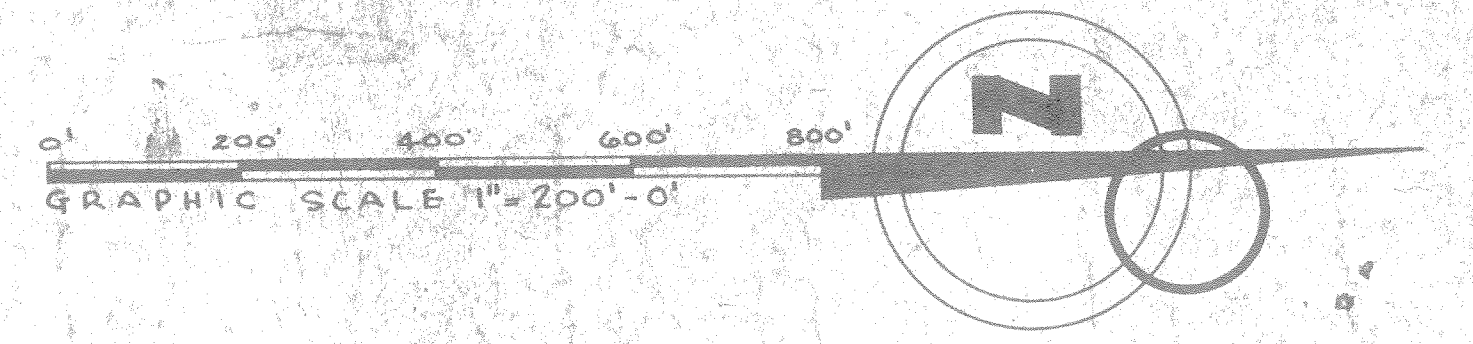

UTILITY LEGEND

SANITARY SEWER

PROPOSED SANITARY SEWER

STORM SEWER

PROPOSED STORM SEWER

WATER LINE

PROPOSED WATER LINE

SYMBOLS

- V - WATER VALVE
- FH - FIRE HYDRANT
- MH - MANHOLE
- CO - CLEANOUT
- LDI - LAWN DROP INLET
- JB - JUNCTION BOX

REV. A - ADDED 6" WATER TIE LINE FROM MONTFORD POINT T.D. 8/28/47

EDWARDS AND McKIMMON - LEIF VALAND
ARCHITECTS - RALEIGH, NORTH CAROLINA

EUGENE R. MARTINI
LANDSCAPE ARCHITECT, ATLANTA, GEORGIA

APPROVED DATE
Stephen Paxon 12 Aug. 1947
ENGINEER DISTRICT ENGINEER
Y.P.D. DRAWING NO. 6
CL-4



TT#2

CAMP LEJEUNE HOUSING PROJECT II

NEW RIVER, NORTH CAROLINA

TARAWA TERRACE II

OVERALL UTILITY PLAN

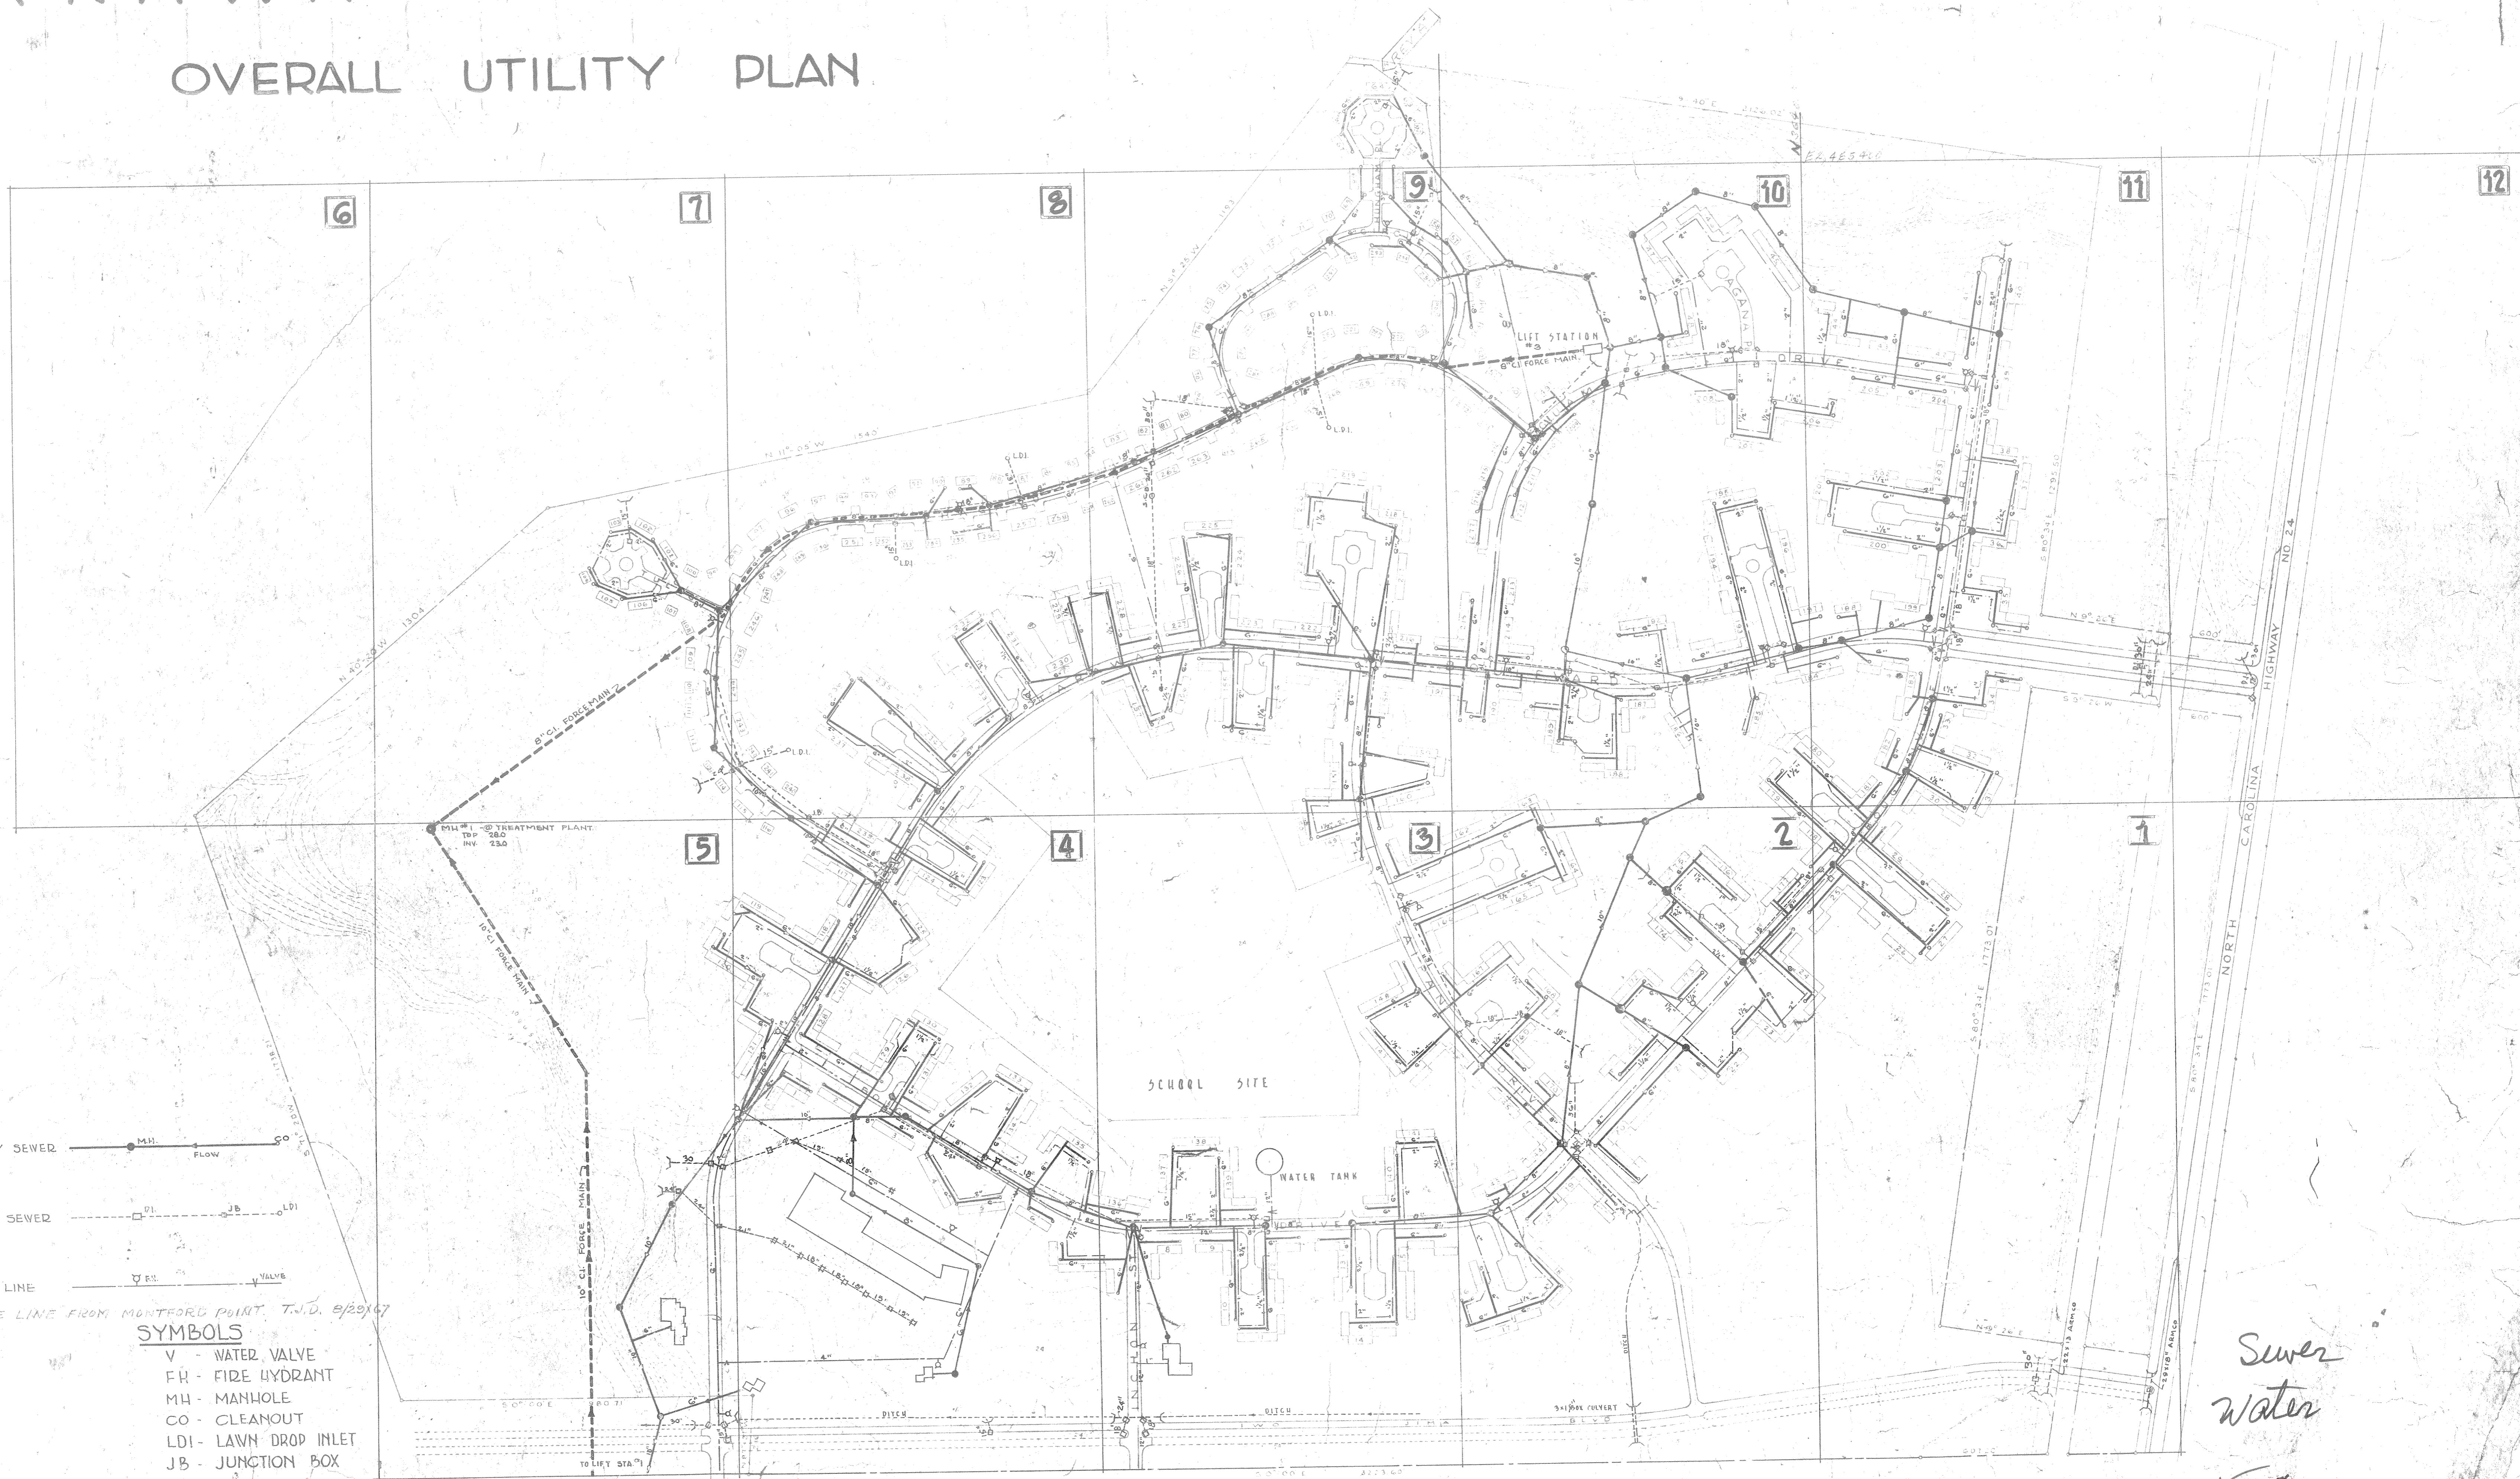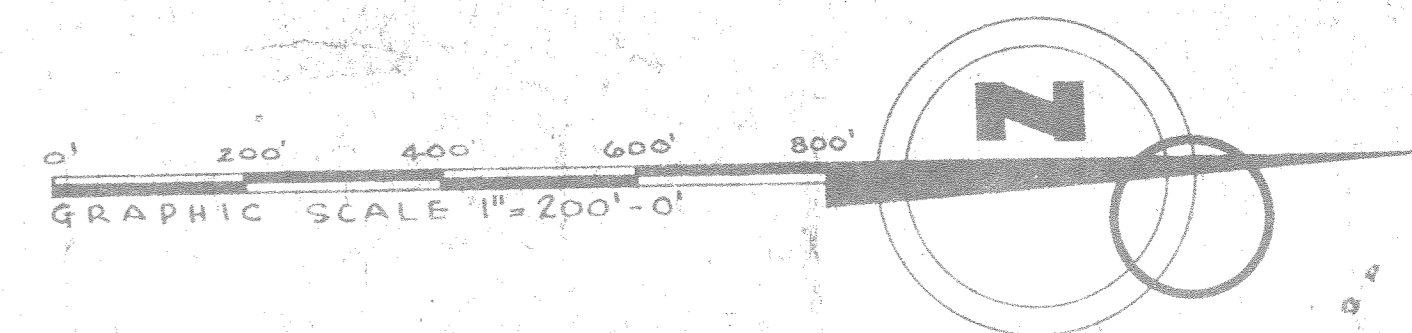

UTILITY LEGEND

- SANITARY SEWER**
PROPOSED SANITARY SEWER
- STORM SEWER**
PROPOSED STORM SEWER
- WATER LINE**
PROPOSED WATER LINE

REV. A - ADDED 8" WATER TIE LINE FROM MONTFORD POINT, T.O.D. 8/20/67

- SYMBOLS**
- V - WATER VALVE
 - FH - FIRE HYDRANT
 - MH - MANHOLE
 - CO - CLEANOUT
 - LDI - LAWN DROP INLET
 - JB - JUNCTION BOX

*Sewer
Water*

TT 2

EDWARDS AND McKIMMON - LEIF VALAND
ARCHITECTS - RALEIGH, NORTH CAROLINA

EUGENE R. MARTINI
LANDSCAPE ARCHITECT, ATLANTA, GEORGIA

APPROVED DATE 12 Aug 1956
By Stephen Payne
REGISTERED PROFESSIONAL PUBLIC WORKS OFFICIAL
STATE OF GEORGIA
V.D. DRAWING NO. 64350
DL-3
CL-41

TT #2 winter sheet

451