

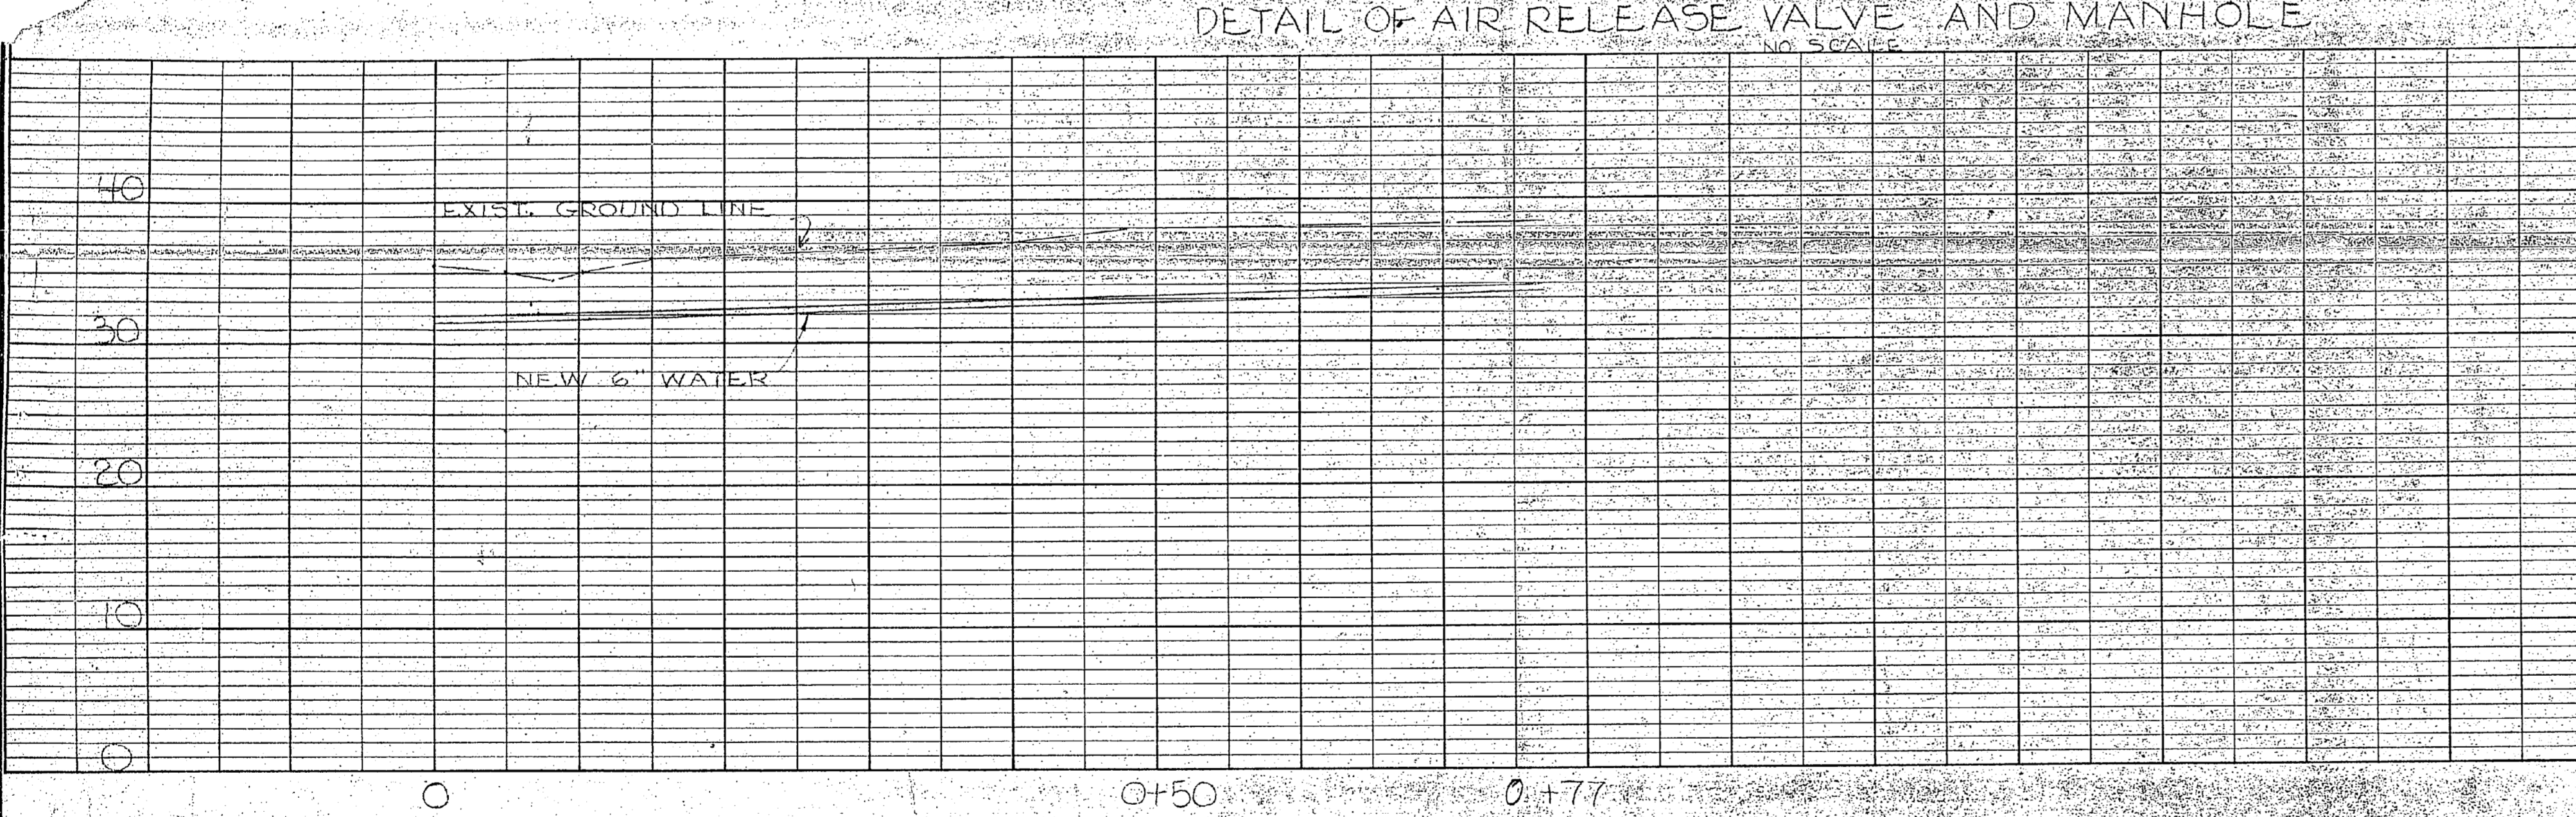


- ELECTRICAL CONSTRUCTION NOTES**
1. INSTALL NEW 3/C NO. 4 UNDERGROUND CABLE #1 NO. 4 BARE NEUTRAL WIRE BURIED TO A DEPTH OF 24 INCHES WITH 1x6 CREOSOTED PLANKS, PROVIDING PROTECTIVE COVER. 2 INCH CONDUIT SLEEVES SHALL BE INSTALLED AT ENTRANCE TO BLDG. AND UP POLE.
 2. INSTALL THREE 75 KVA 12470/240/120 VOLT TRANSFORMERS TO BE FINISHED BY THE GC. COMPLETE WITH NEW 9KV LIGHTNING ARRESTERS, NEW 15KV FUSE CUTOUTS, NEW CROSS ARMS, NEW INSULATORS, NEW HARDWARE ETC. ON NEW POLE. CONNECT PRIMARY-DELTA AND SECONDARY-WYE FOR 120/208 Y-3Ø, 4 WIRE SECONDARY SERVICE.

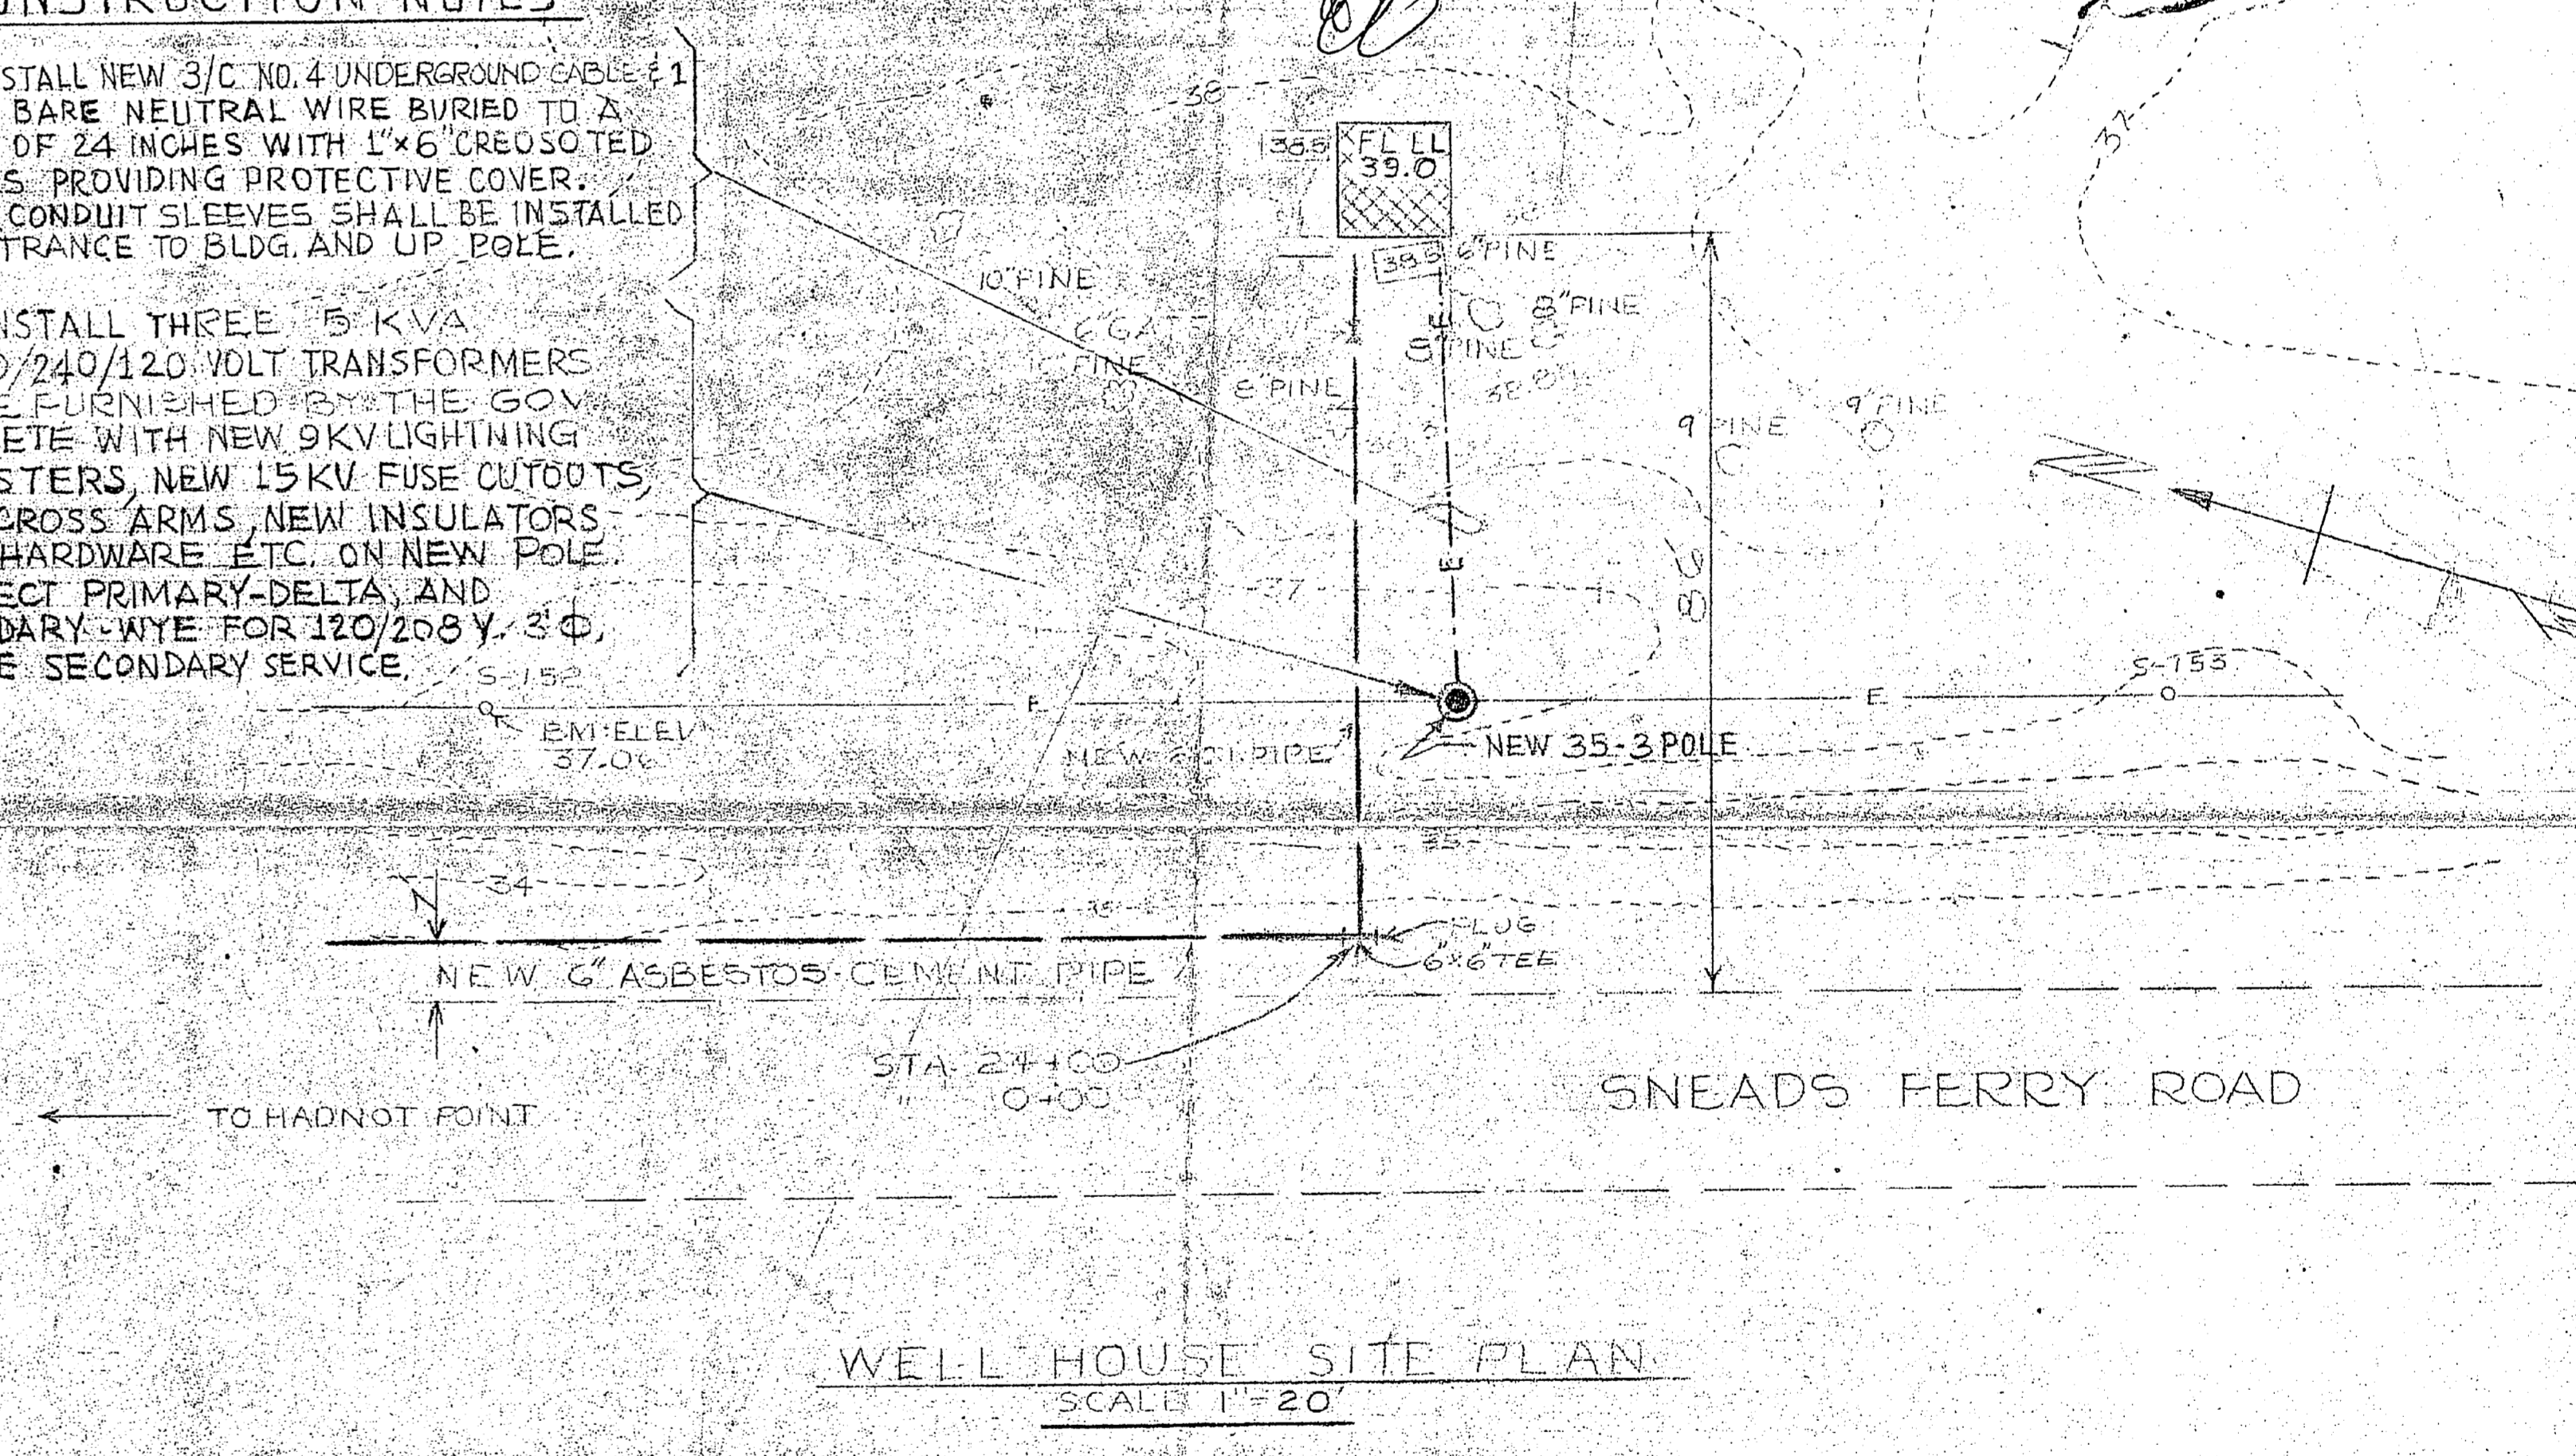

- LEGEND**
- EXIST. BLDG. & ROADS
 - EXIST. WATER LINE
 - - - EXIST. ELECTRIC LINE & POLE
 - EXIST. CONTOUR LINES
 - NEW BLDG.
 - NEW WATER LINE & VALVE
 - NEW ELECTRIC LINE
 - FINISHED GRADE

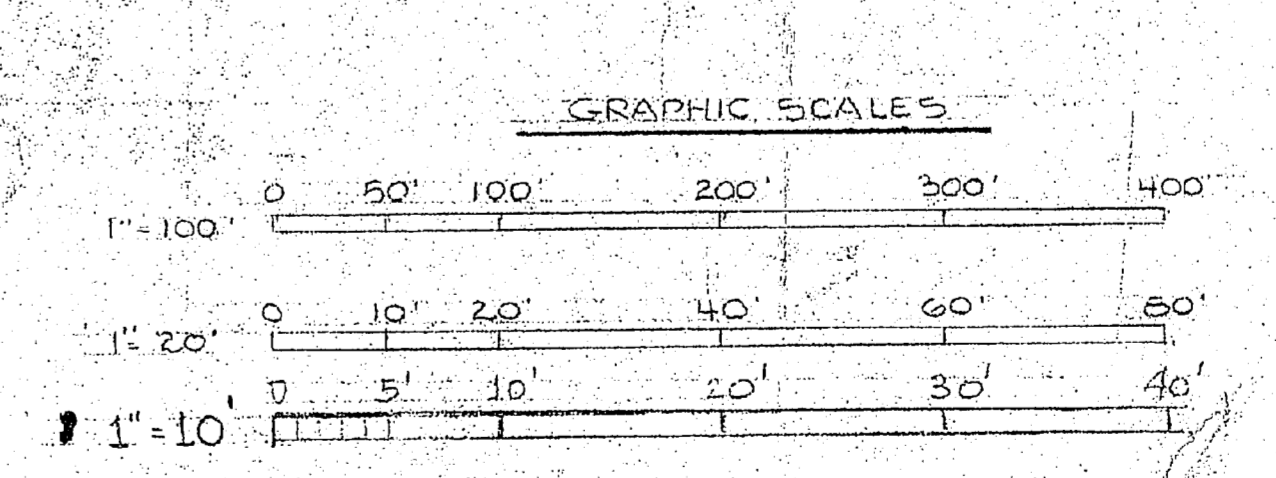

REVISION	DATE	APPD.	DESCRIPTION
P.W. DRAWING NO. 10804			MARINE CORPS CAMP LEJEUNE, N. C.
DESIGNER: [Signature]			NEW RAW WATER W. HADNOT POINT WATER SYSTEM
DRAWN: [Signature]			SITE AND UTILITY PLAN
CHK: [Signature]			CONNECTING WATER MAIN AND ETC.
SUPPLIES: [Signature]			
IN CHARGE: [Signature]			
APPROVED: [Signature]			DATE: 11 Nov 73
APPROVED FOR BUREAU OF YARDS & DOCKS: [Signature]			SCALE: GRAPHIC SPEC 7525/58
DATE: [Blank]			SHEET: 3 OF 3 NGY 7525
DATE: [Blank]			Y & D. NO. 84700

SATISFACTORY TO THE QUARTERMASTER GENERAL OF THE MARINE CORPS

